


Computer Filename:   
 Revisions:   
 Date:   
 1   
 2   
 3   
 4   
 5   
 6   
 7   
 8   
 9

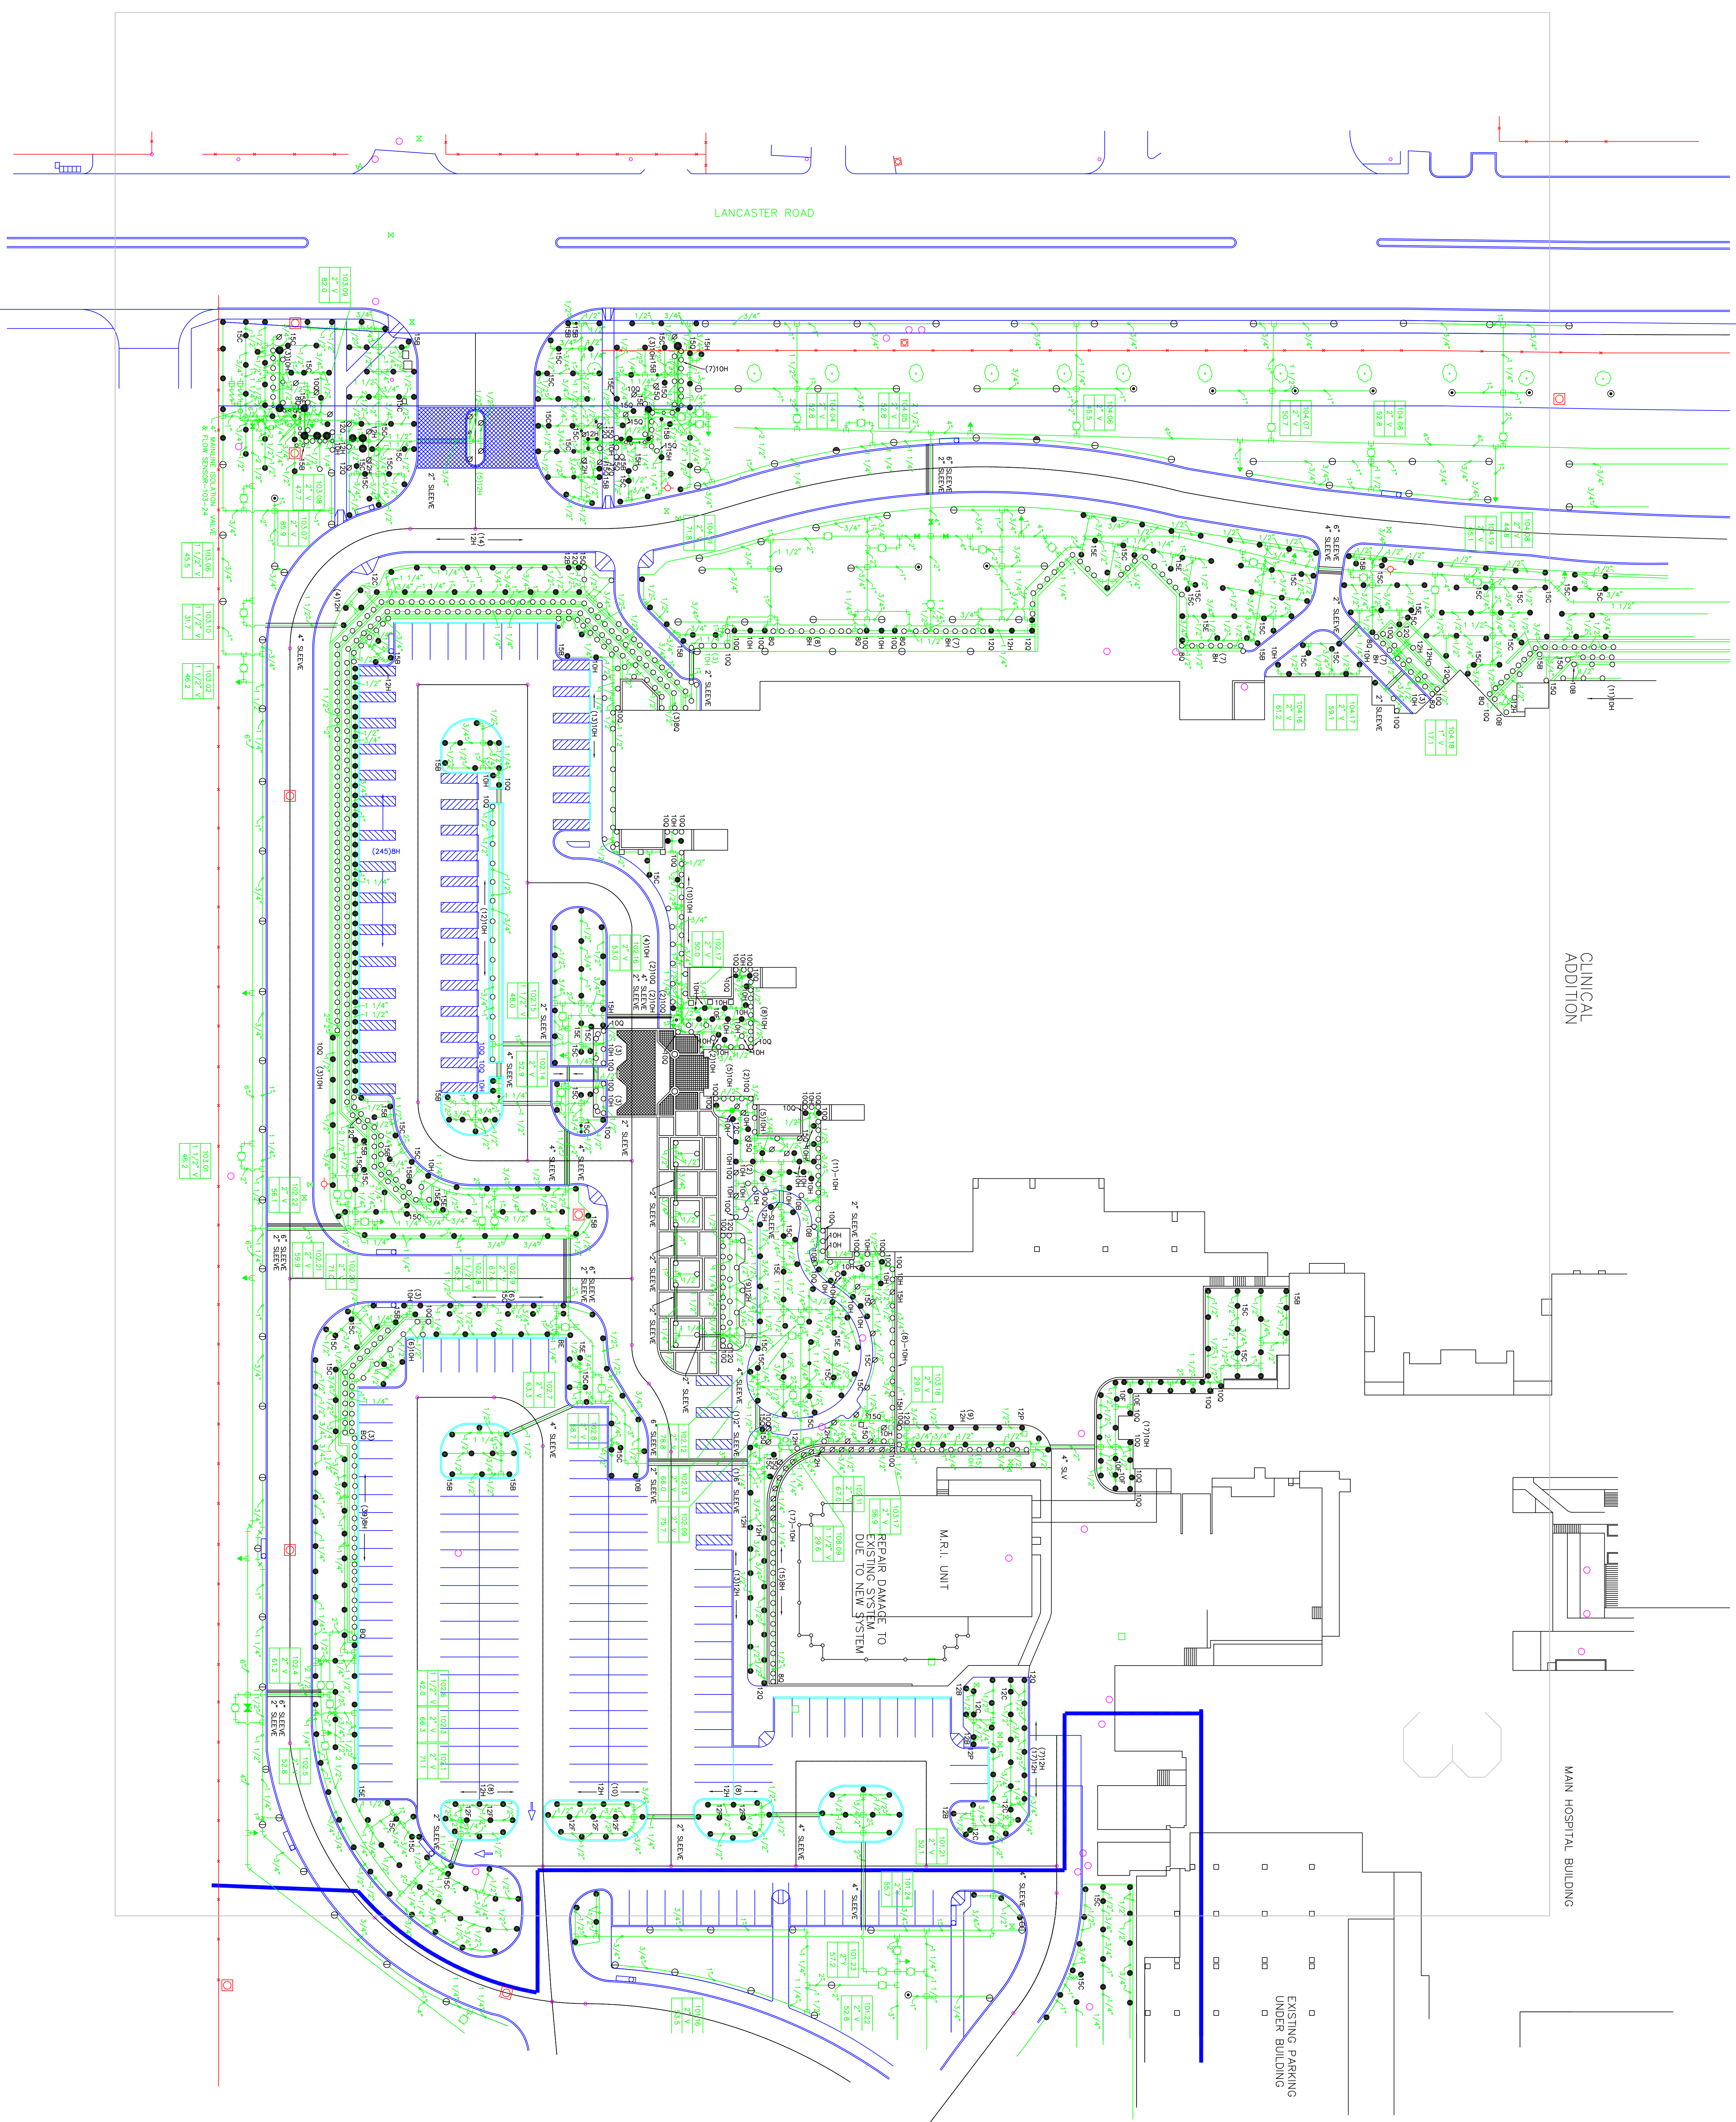


SITE PLAN LEGEND

BLOCKS NAME	SYMBOLS	DESCRIPTION
LWNSPYHD	●	LAWN SPRAY HEAD
FHHDRNT	○	FIRE HYDRANT
MANHOLE	○	MANHOLE
WATERMTR	○	WATER METER
SURFINLT	⊞	SURFACE INLET
VALVE	⊞	VALVE
HPPSPYHD	⊞	HIGH-POP SPRAY HEAD
LWNSPYHD	■	LAWN END STRIP HEAD
QCV	▲	QUICK COUPLING VALVE
ESRISR	⊞	END STRIP RISER
LWNSCHD	▣	LAWN CENTER STRIP HEAD
SPCRH	⊞	SMALL PART-CIRCLE ROTARY HEAD
FORCHD	⊞	FULL CIRCLE ROTARY HEAD
PORTHD	⊞	PART-CIRCLE ROTARY HEAD
SHDRSR	○	SHRUB HEAD ON RISER
CSNRSR	□	CENTER STRIP ON RISER
RCVALVE	⊞	REMOTE CONTROL VALVE
SITCTR	■	SATELLITE CONTROLLER
WFENCE	×	WIRE FENCE
BPDFICE	⊞	BACKFLOW PREVENTION DEVICE
SIMNHOLE	⊞	STORM DRAIN MANHOLE
ESRPHD	▣	END STRIP HEAD
CRSRPHD	▣	CENTER STRIP HEAD
CURBINLT	▣	CURB INLET
GATVALVE	▣	GATE VALVE
TREE	⊞	TREE
ELBOW-0	-	ELBOW-0
ELBOW-90	┌	ELBOW-90
TIE-PLAN	⊞	TIE-PLAN
CONTAIN	⊞	FOR CONTINUATION
CROSS	⊞	CROSS
COL2	⊞	RECTANGULAR CONCRETE COLUMN

Drawing Title  
**V.A. Site Irrigation Plan**  
 Section 3  
 Approved Area Project Manager

Project Title:   
 Building Number:   
 Location: **4500 S. Lancaster Rd. Dallas, Texas 75216**

Date:   
 Project No:   
 Drawing No:   
 Page of:

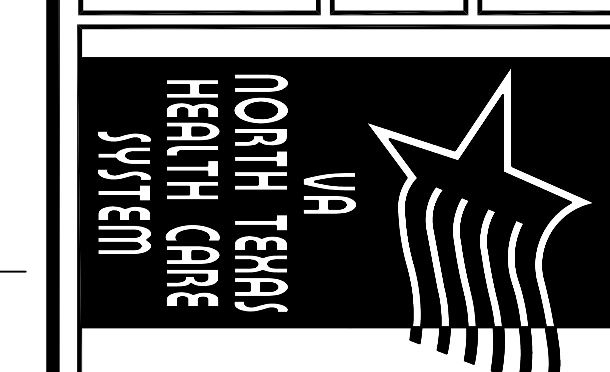

VANTHCS  
 Dallas, Texas